



NORTH

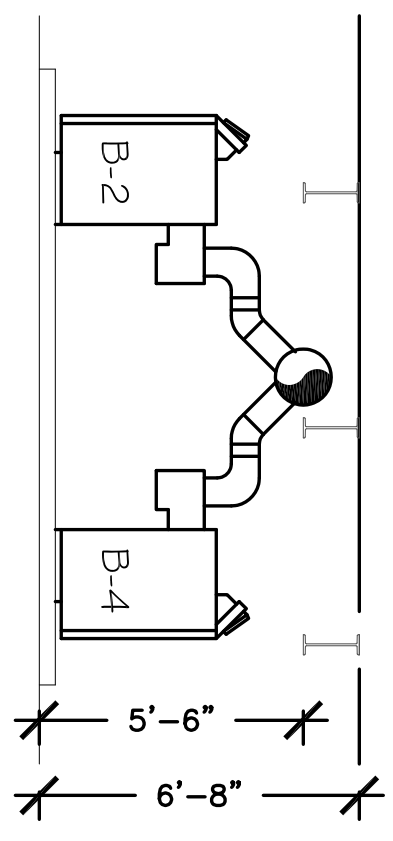

1 BOILER SECTION  
SCALE: 1/4"=1'-0"

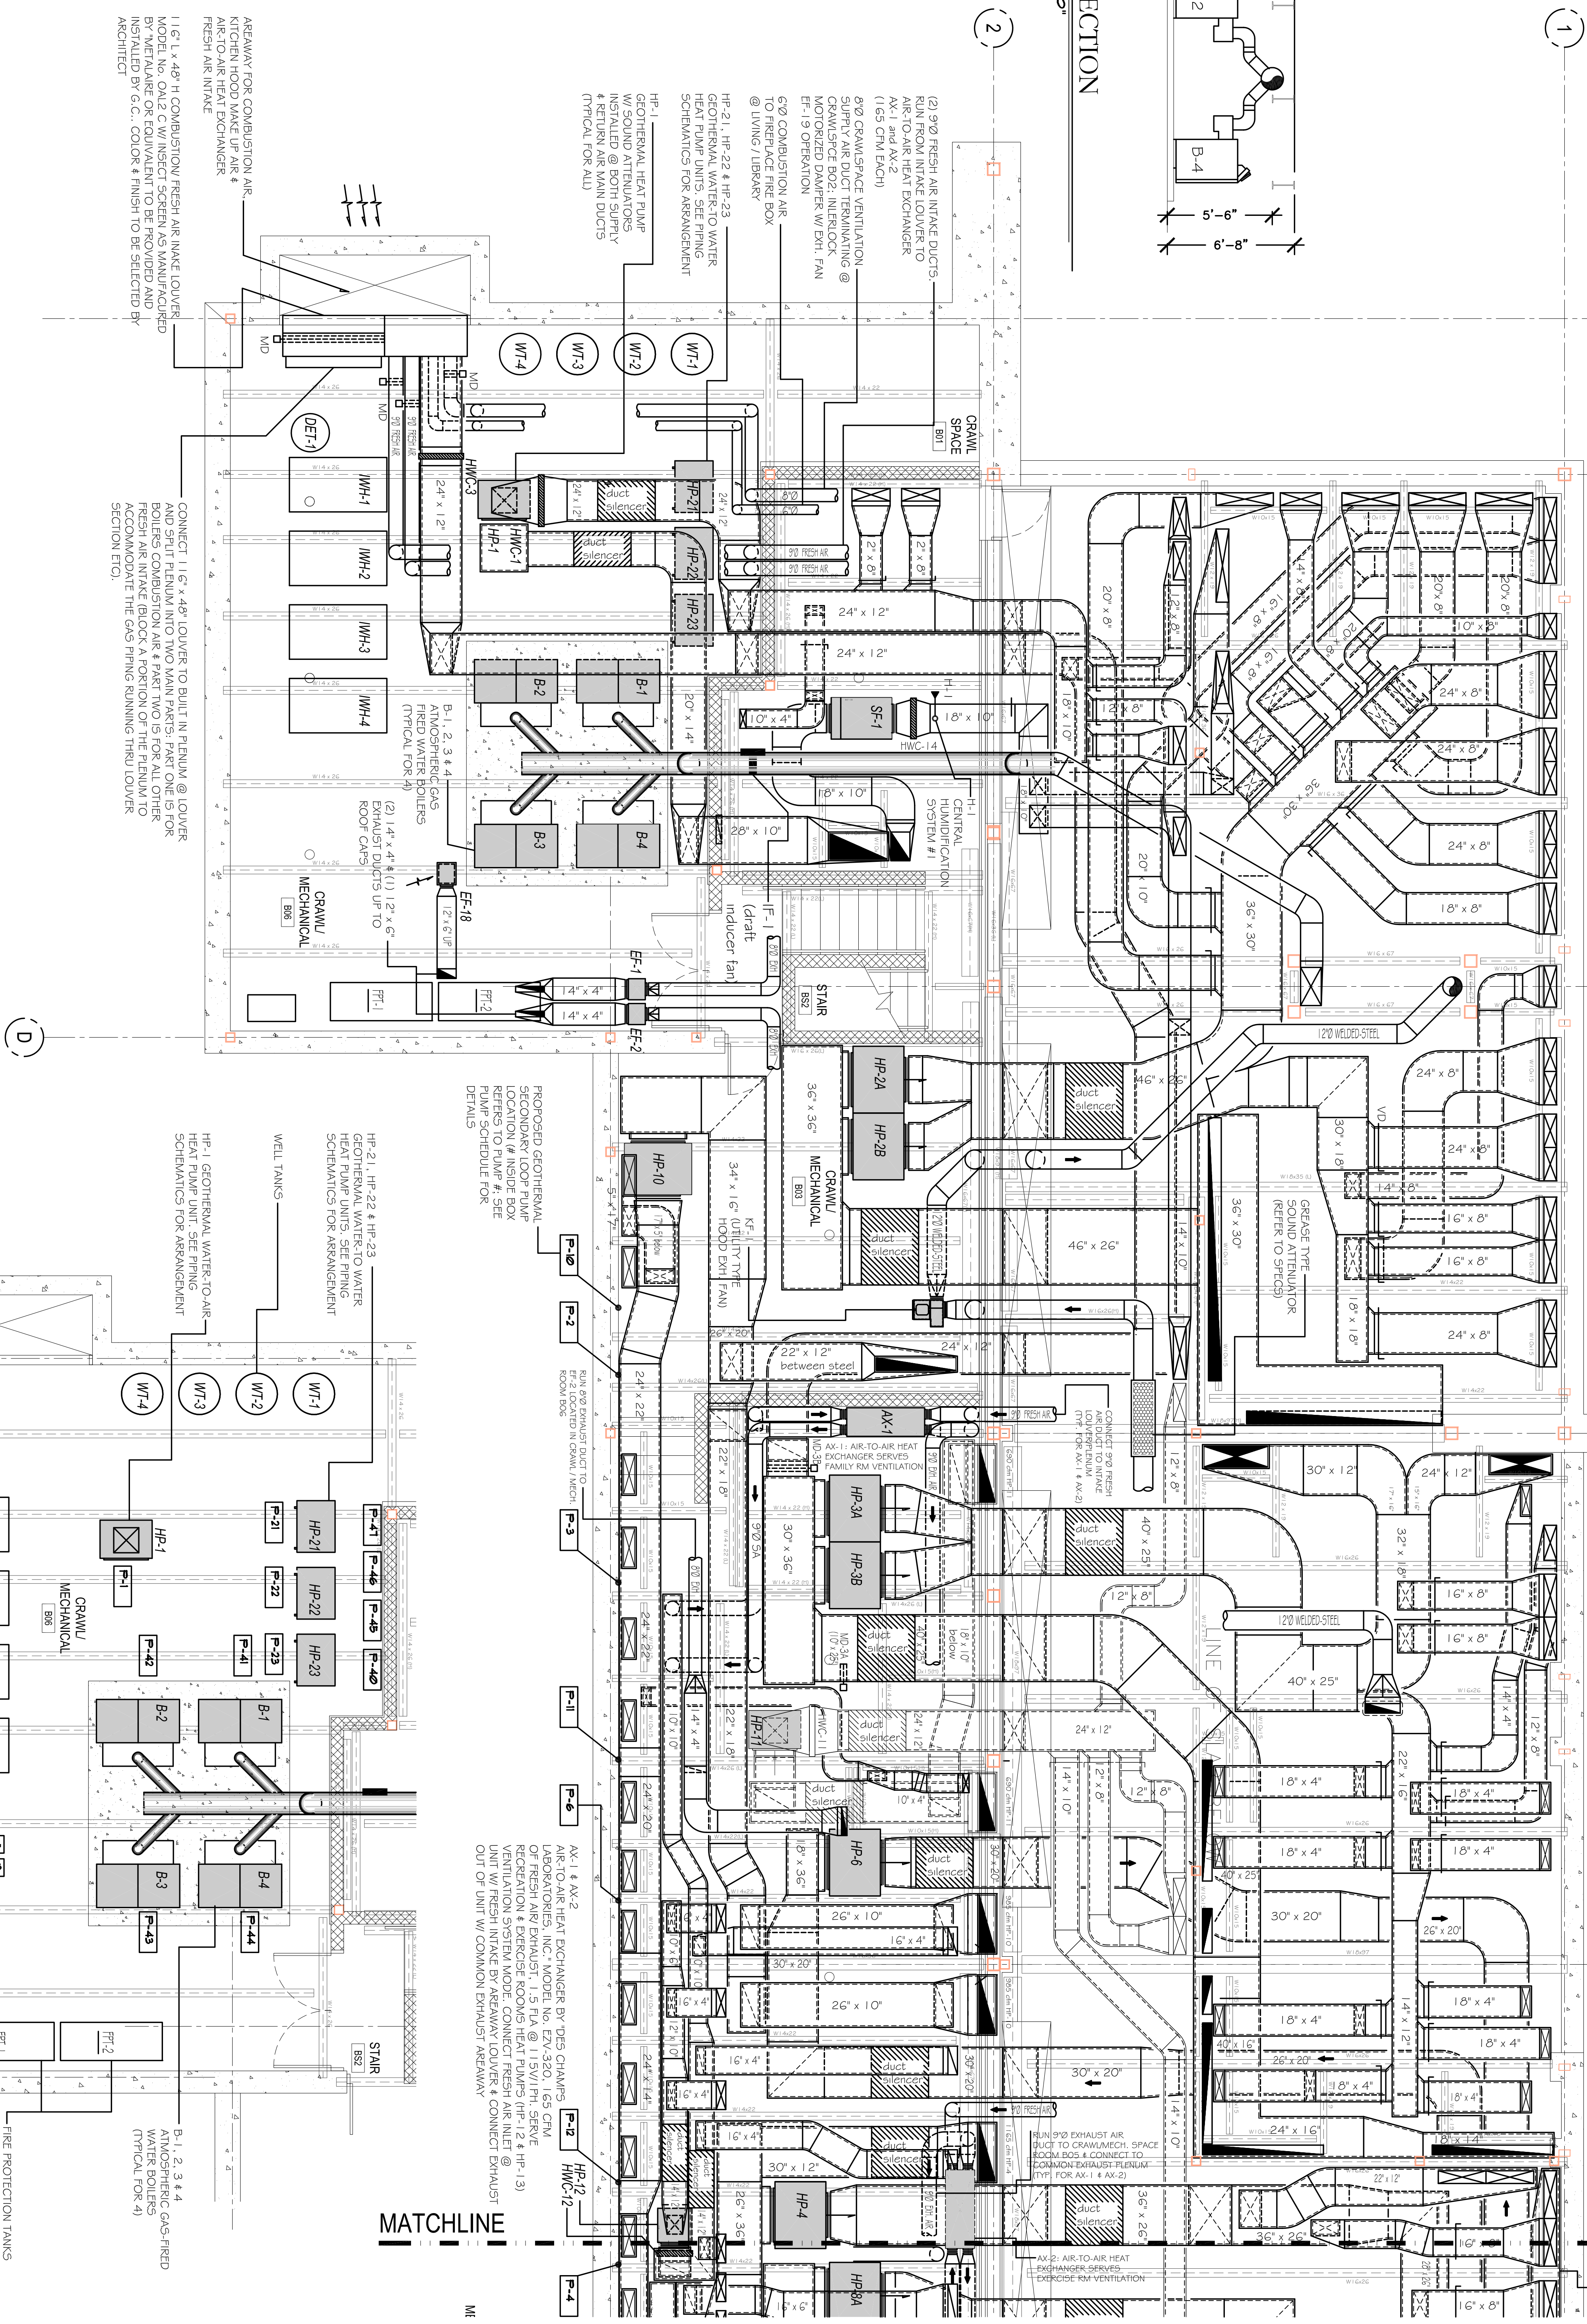

DUCT SPACES SHOWN ARE CLEAR INSIDE DIMENSIONS. ADD INTERNAL LINER THICKNESS WHERE INTERNAL LINER IS SPECIFIED. ADD LINER THICKNESS FOR OVERALL DUCT DIMENSION.

2 BOILER ROOM EQUIPMENT LAYOUT PLAN  
SCALE: 1/4"=1'-0"

GROUND SOURCE GEOTHERMAL HEAT PUMP SYSTEMS PROVIDE HEATING, COOLING, 80% OF DOMESTIC HOT WATER PRODUCTION & 80% SNOW MELT

**Caesyr Rocha, LLC**  
Consulting Engineers  
46 Stonybrook Rd  
Naugatuck, CT 06770  
Tel: 203-729-8877  
Fax: 203-729-8881  
E-mail: caesyr10@csyglobal.net

**12,000 SQ. FT RESIDENCE SAMPLE #1**

**BASEMENT FLOOR SOUTH HVAC PLAN**

Sample #1

SCALE: 1/4" = 1'-0"

DATE: September 28, 2011

**M-1**